


2 PELTZ GYM - PART PLAN ELECTRICAL
1" = 20'-0"

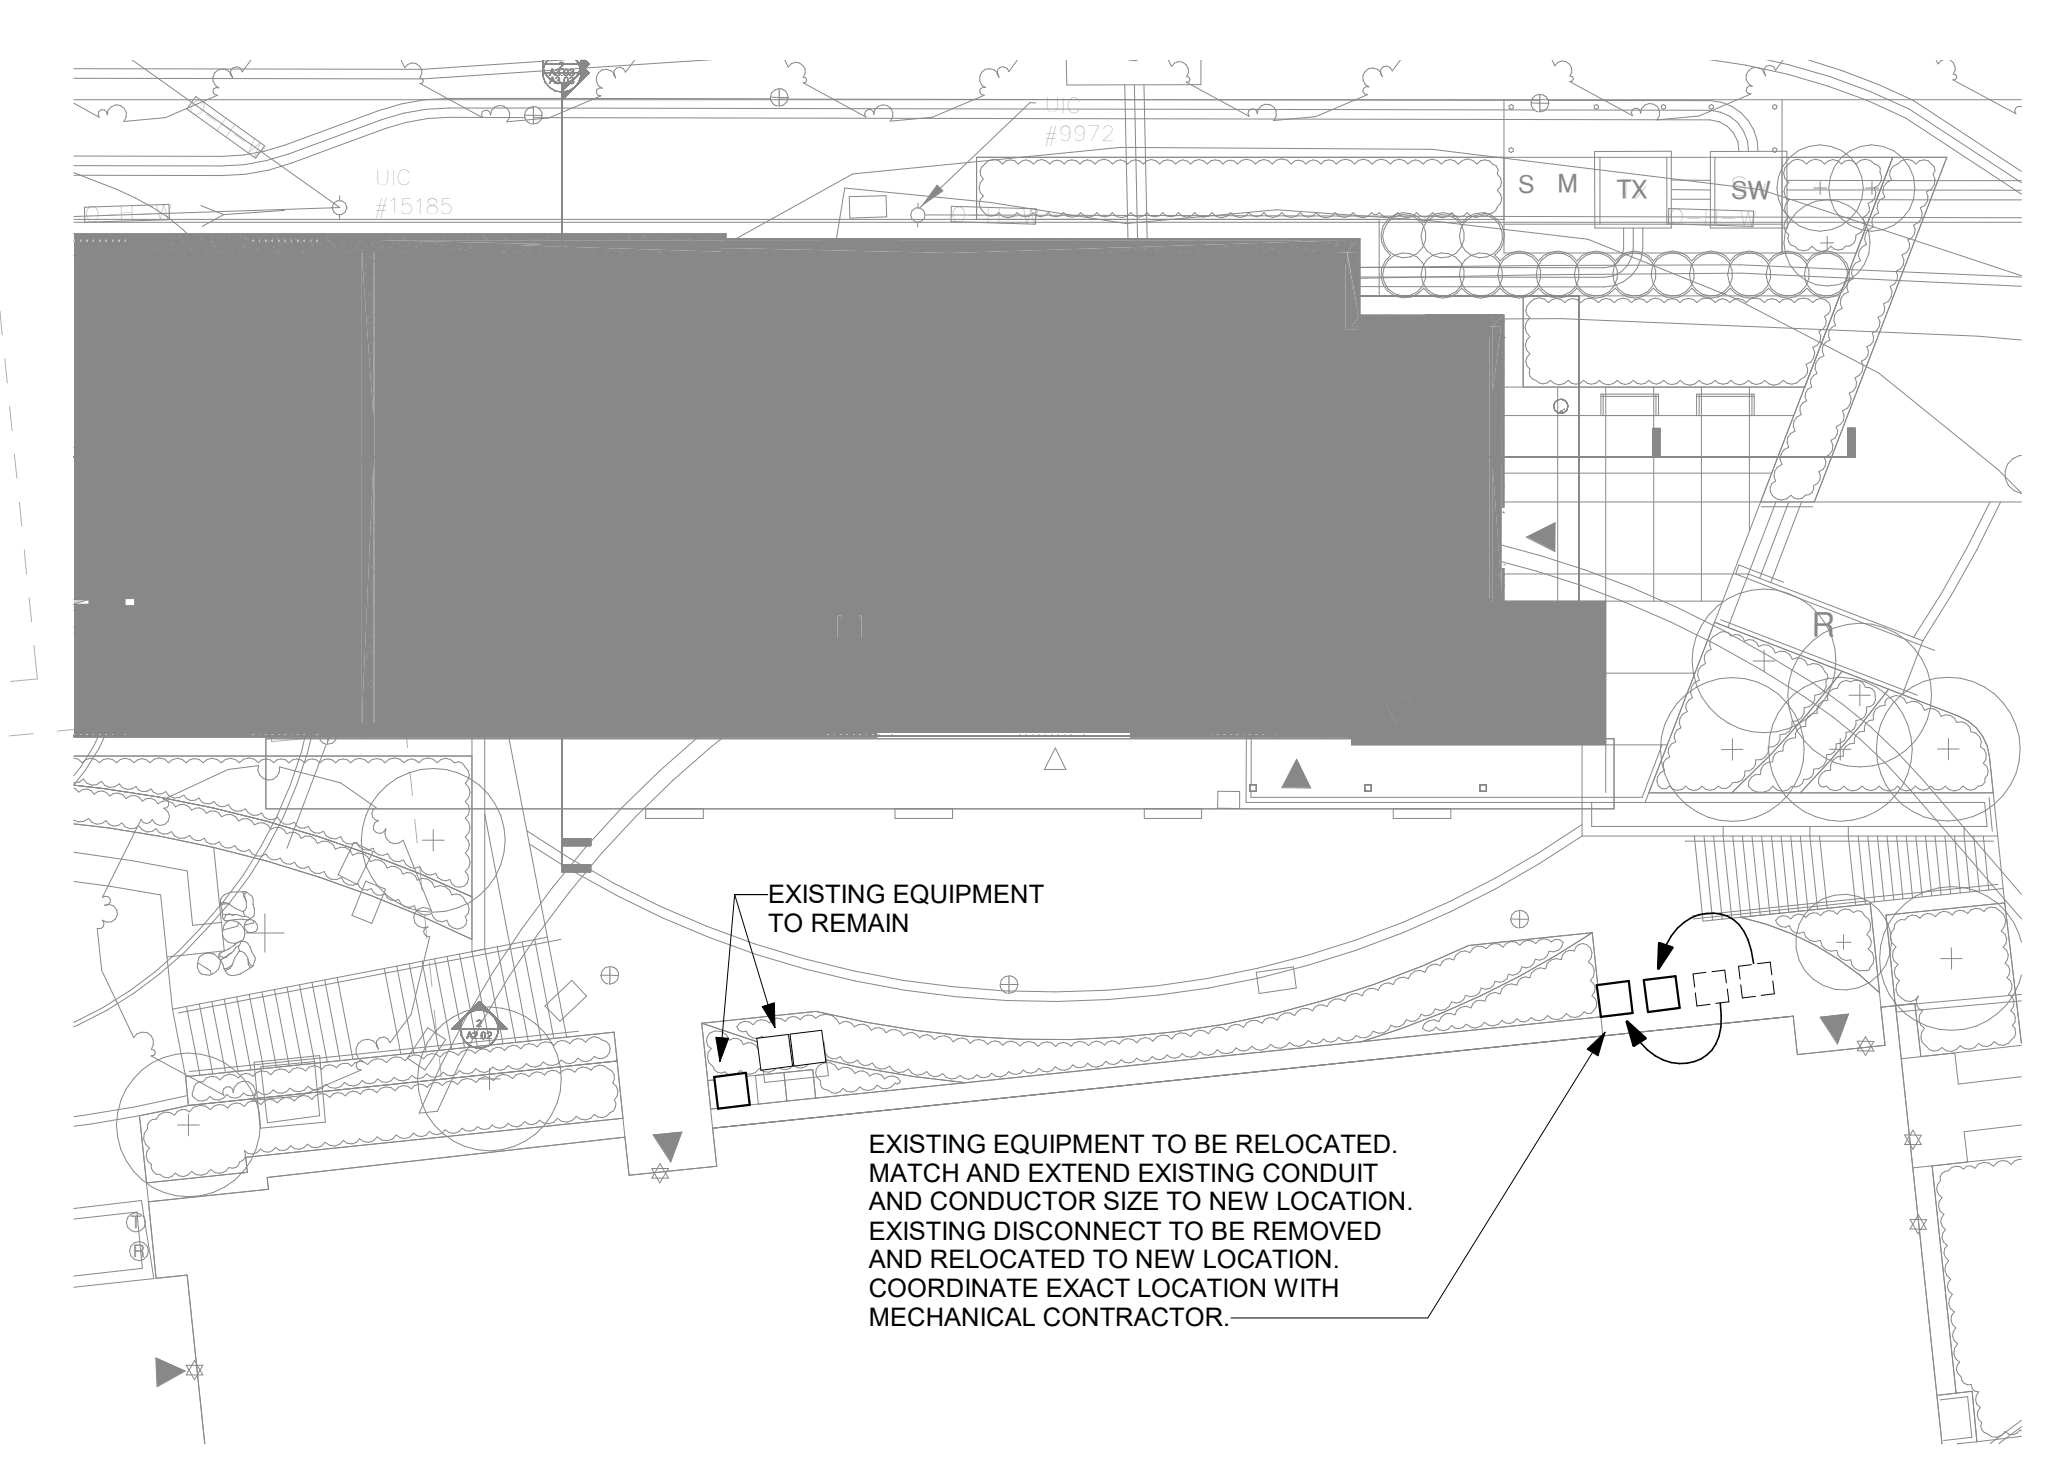

- SPECIAL SYSTEMS DRAWING NOTES:**
- 1 PROVIDE MANUAL PULL STATION MOUNTED TO MULLION. COORDINATE ROUTING OF CONDUIT WITHIN MULLION WITH MANUFACTURER.
 - 2 PROVIDE POWER FOR ELECTRONIC PLUMBING FIXTURES. REFER TO DETAILS FOR ADDITIONAL INFORMATION.
 - 3 PROVIDE POWER FOR ELECTRIC HEATING CABLES. REFER TO HVAC DRAWINGS FOR CONTROLLER LOCATION.
 - 4 PROVIDE 3/4" CONDUIT AND CONTROL WIRING FROM RAIN SENSOR TO IRRIGATION CONTROLLER. COORDINATE LOCATION WITH ARCHITECT.
 - 5 PROVIDE POWER FOR IRRIGATION CONTROLLER. COORDINATE LOCATION WITH ARCHITECT.
 - 6 PROVIDE POWER FOR MOTORIZED WINDOW SHADES. COORDINATE LOCATION WITH ARCHITECT.
 - 7 PROVIDE 1" CONDUIT AND CONTROL WIRING BETWEEN FORCEFEED AND WALL MOUNTED JUNCTION BOX. COORDINATE WIRING TERMINATIONS WITH OWNER. COORDINATE LOCATION WITH ARCHITECT.
 - 8 PROVIDE POWER AND CONTROL WIRING FOR MOTORIZED WALL PARTITION. COORDINATE LOCATION WITH ARCHITECT.
 - 9 PROVIDE DEDICATED GROUNDING OF THE SOUND BOOTHS. COORDINATE LOCATION OF CONNECTION WITH MANUFACTURER.
 - 10 PROVIDE POWER AND WHIP FOR ELECTRIC WATER COOLER. PROVIDE SMA GROUND FAULT CIRCUIT BREAKER. COORDINATE EXACT LOCATION WITH MANUFACTURER.
 - 11 PROVIDE POWER FOR ERU EMERGENCY MODE SUPPLY FANS. COORDINATE EXACT LOCATION WITH MANUFACTURER.
 - 12 PROVIDE POWER AND CONTROLS FOR AUTOMATIC DOOR OPERATORS. COORDINATE LOCATION OF PUSH PLATES WITH ARCHITECTURAL DRAWINGS.
 - 13 PROVIDE POWER FOR IRRIGATION BOOSTER PUMP. COORDINATE LOCATION WITH MANUFACTURER.
 - 14 PROVIDE ADDRESSABLE INTERFACE DEVICE (AID) FOR HOOD FIRE SUPPRESSION SYSTEM CONTROL PANEL. COORDINATE EXACT LOCATION IN FIELD WITH MANUFACTURER.
 - 15 PROVIDE POWER FOR ELECTRIC HEAT TRACE CONTROLLER. COORDINATE EXACT LOCATION WITH MECHANICAL CONTRACTOR.

drawing title TERRACE LEVEL ELECTRICAL SPECIAL SYSTEMS PLAN		STATE OF CONNECTICUT DEPARTMENT OF ADMINISTRATIVE SERVICES	
professional seal	REVISIONS	drawing prepared by BVH INTEGRATED SERVICES 206 WEST NEWBERRY ROAD BLOOMFIELD, CT. 06002	date 08/16/2019 scale As indicated
	mark date description	project SCSU NEW HHS BUILDING 501 CRESCENT STREET NEW HAVEN, CT 06050	drawn by MOS approved by AV drawing no. ES1.00
		CAO no. BL-RS-329	